



REVISIONS:

ISSUE DATE:

1st	DEVELOPER REVIEW	07.15.19
2nd	SITE PLAN SUBMITTAL	08.26.19
3rd	SITE COMMENTS	09.05.19
4th	ISSUE FOR PERMIT	10.01.19
5th	ISSUE FOR BID	11.07.19

## EQUIPMENT DISCONNECT SWITCH SUPPORT

NOT TO SCALE | F-401

DRAWN BY: PM / KL / EA

PANDA PROJECT #: S8-20-D7163

ARCH PROJECT #: 19027

**Heights Venture**  
ARCHITECTURE • DESIGN

HOUSTON	DALLAS
1111 North Loop West, Suite 800	5741 Legacy Drive, Suite 320
Houston, Texas 77008	Plano, Texas. 75021
713 869 1103 V	972 490 7292 V

# PANDA EXPRESS

2096 INTERSTATE DR  
OPELIKA, AL, 36801

3600 FSDT

TWW REMODEL




---

E-401

ELECTRICAL DETAILS, DIAGRAMS

TRUE WARM & WELCOME

# BID ISSUE

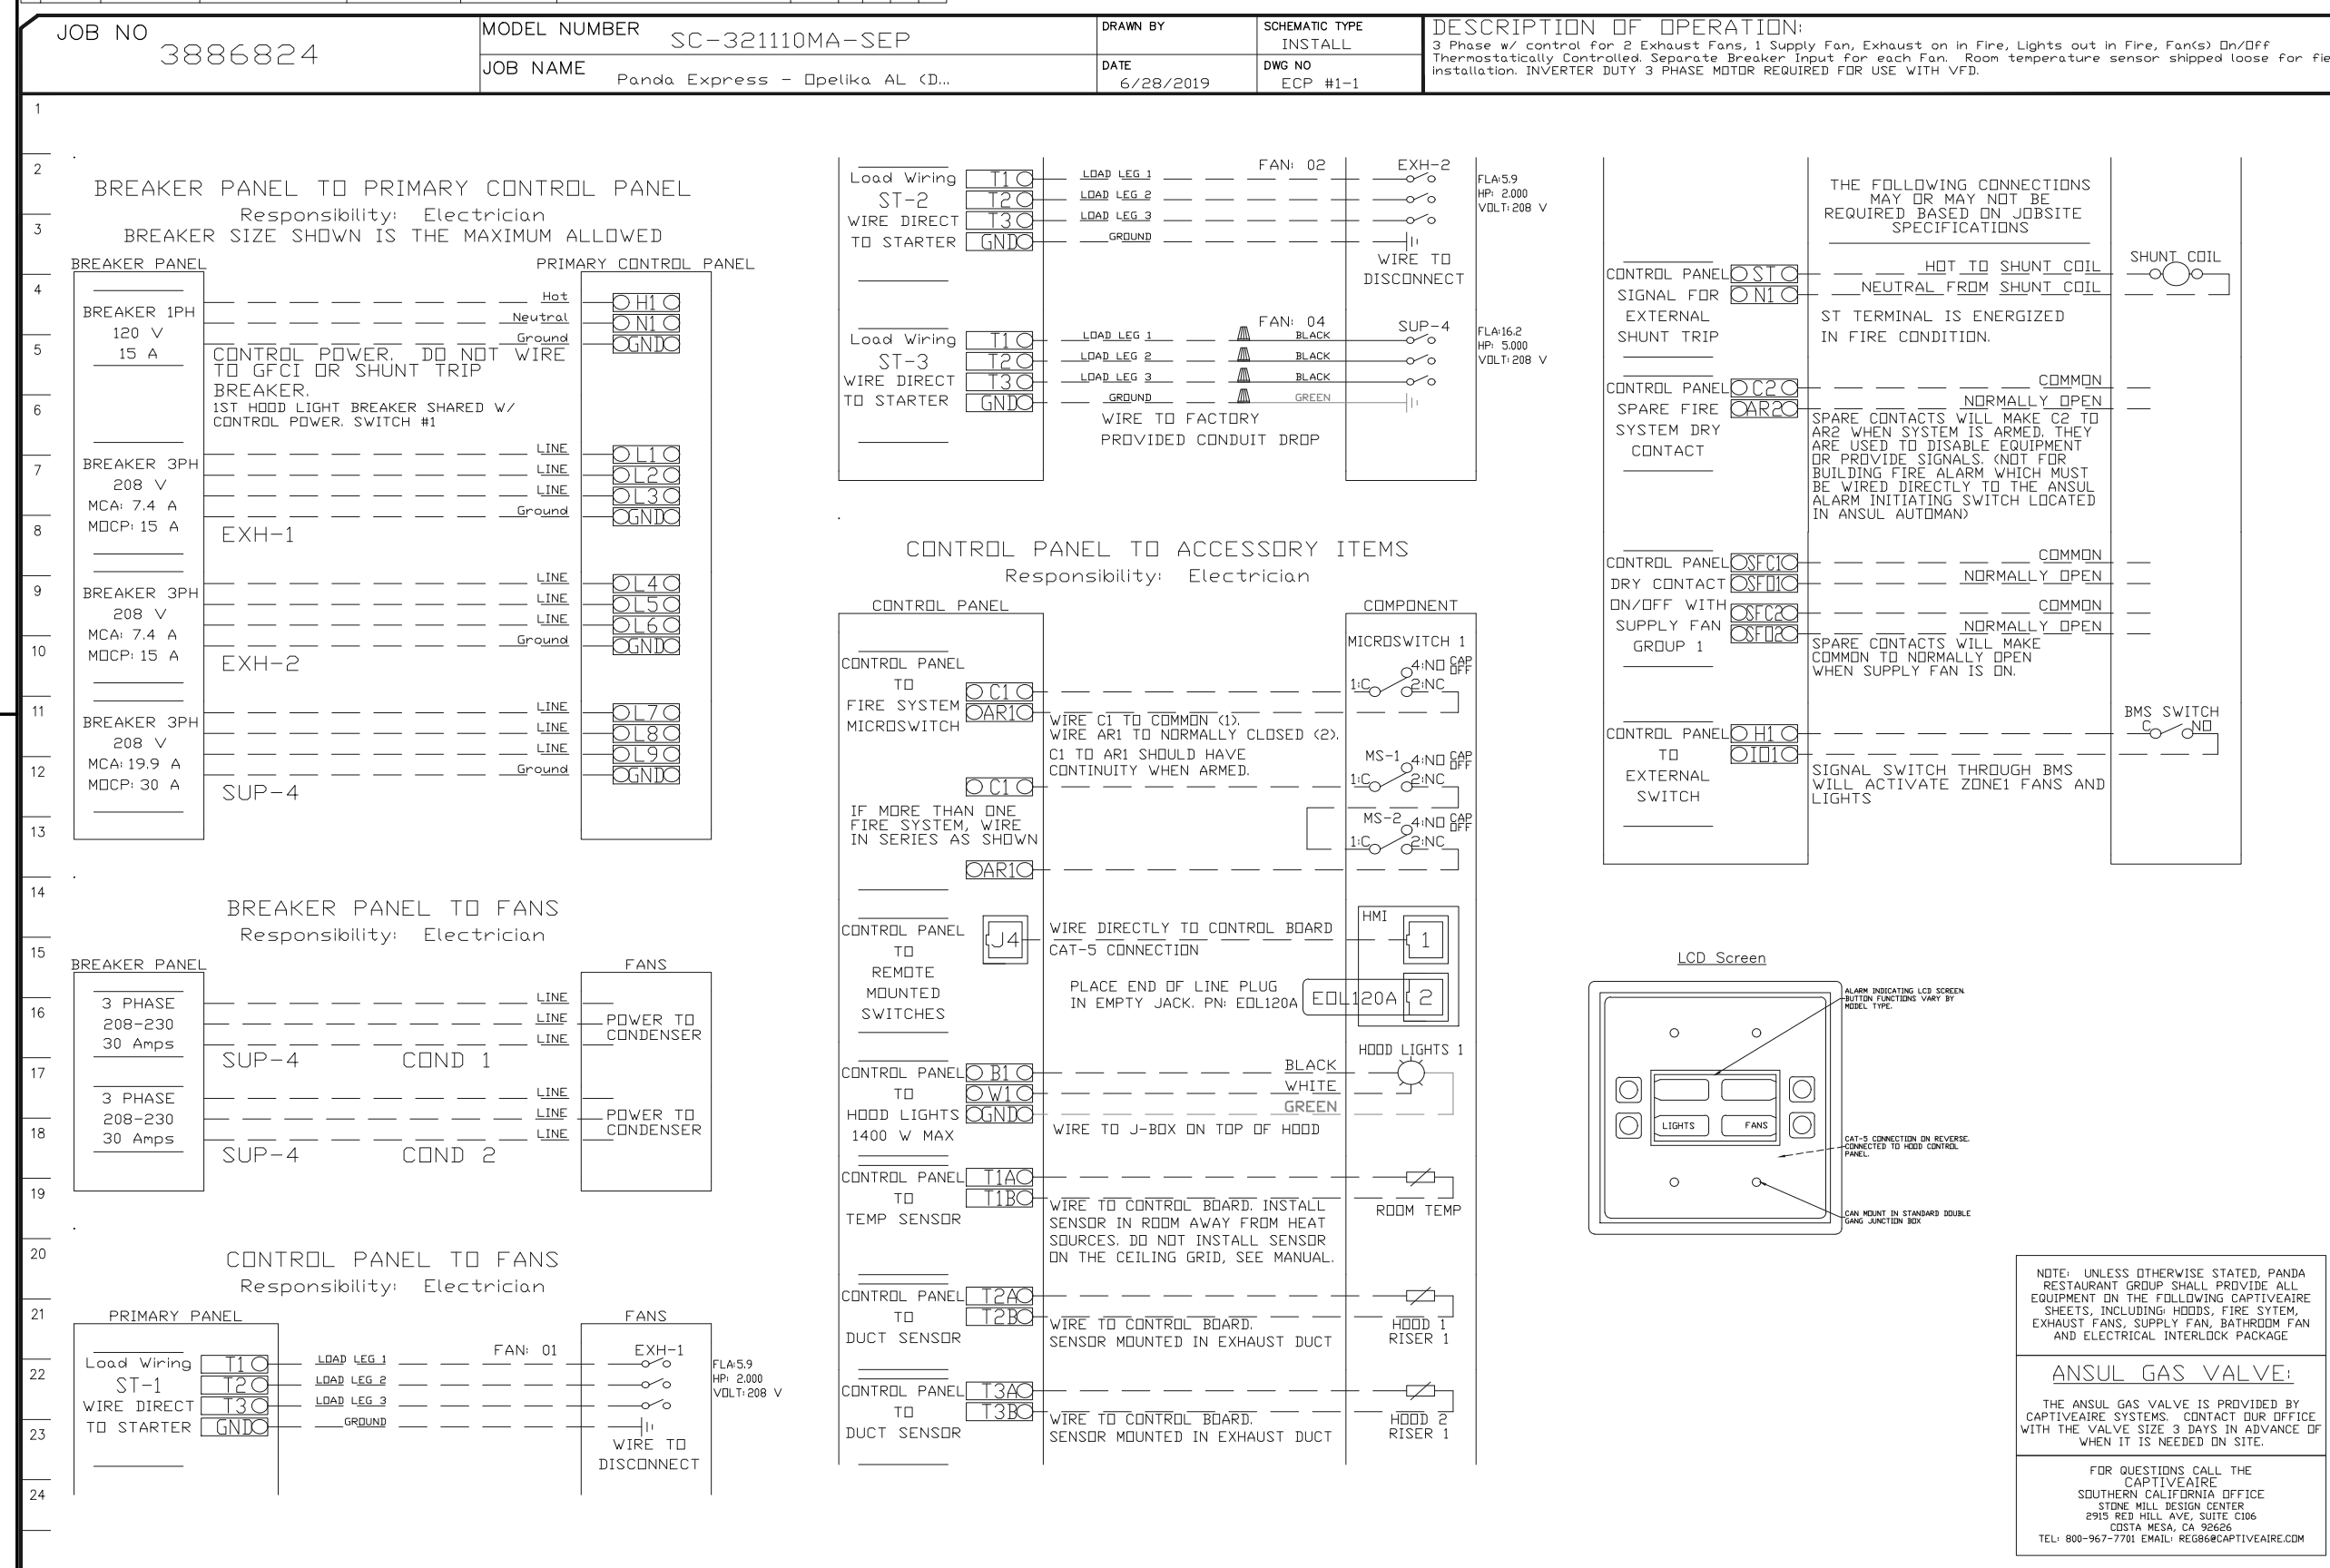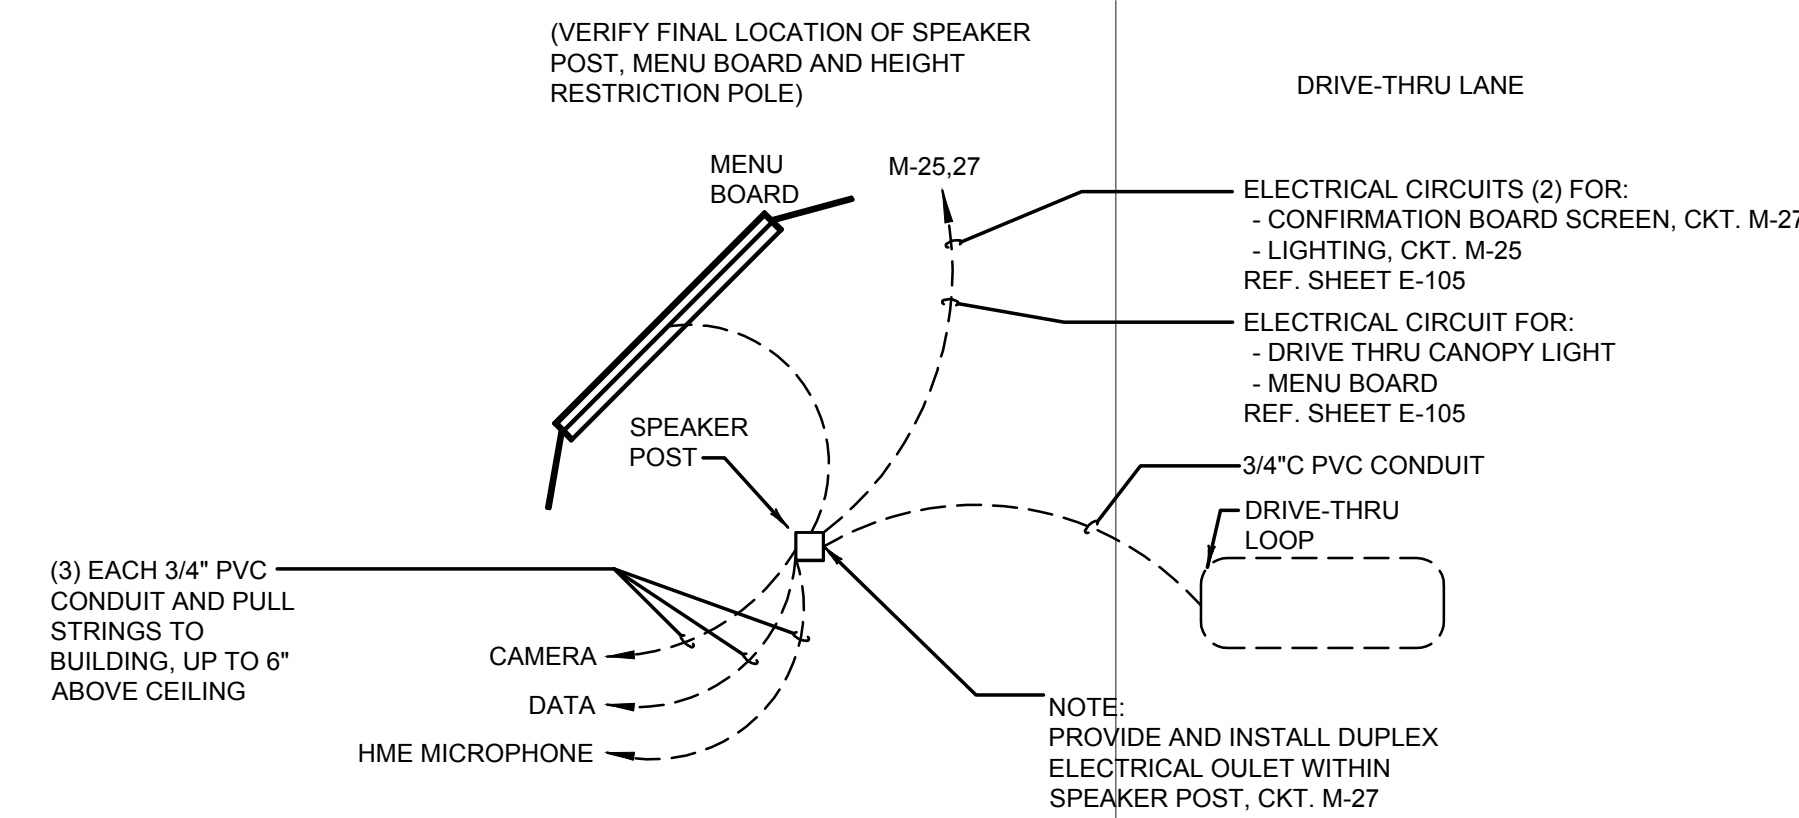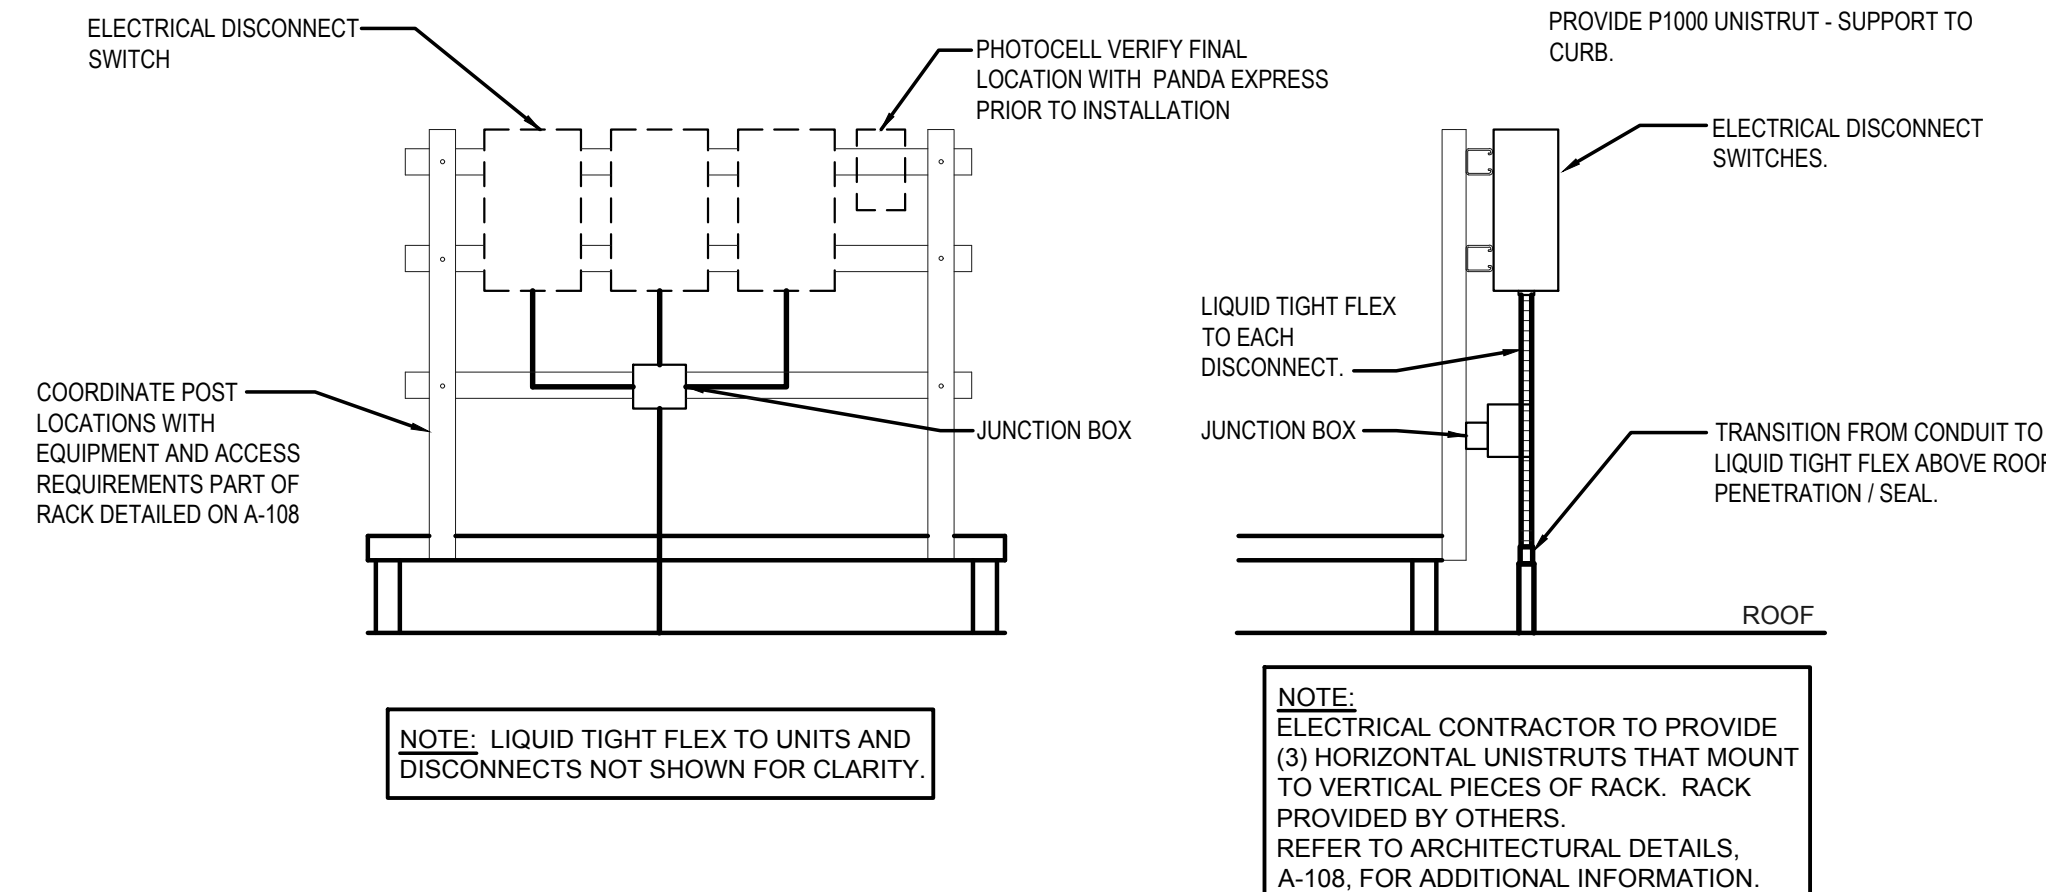

## KITCHEN EXHAUST SYSTEM DIAGRAM

## MENU BOARD & SENSOR LOOP